
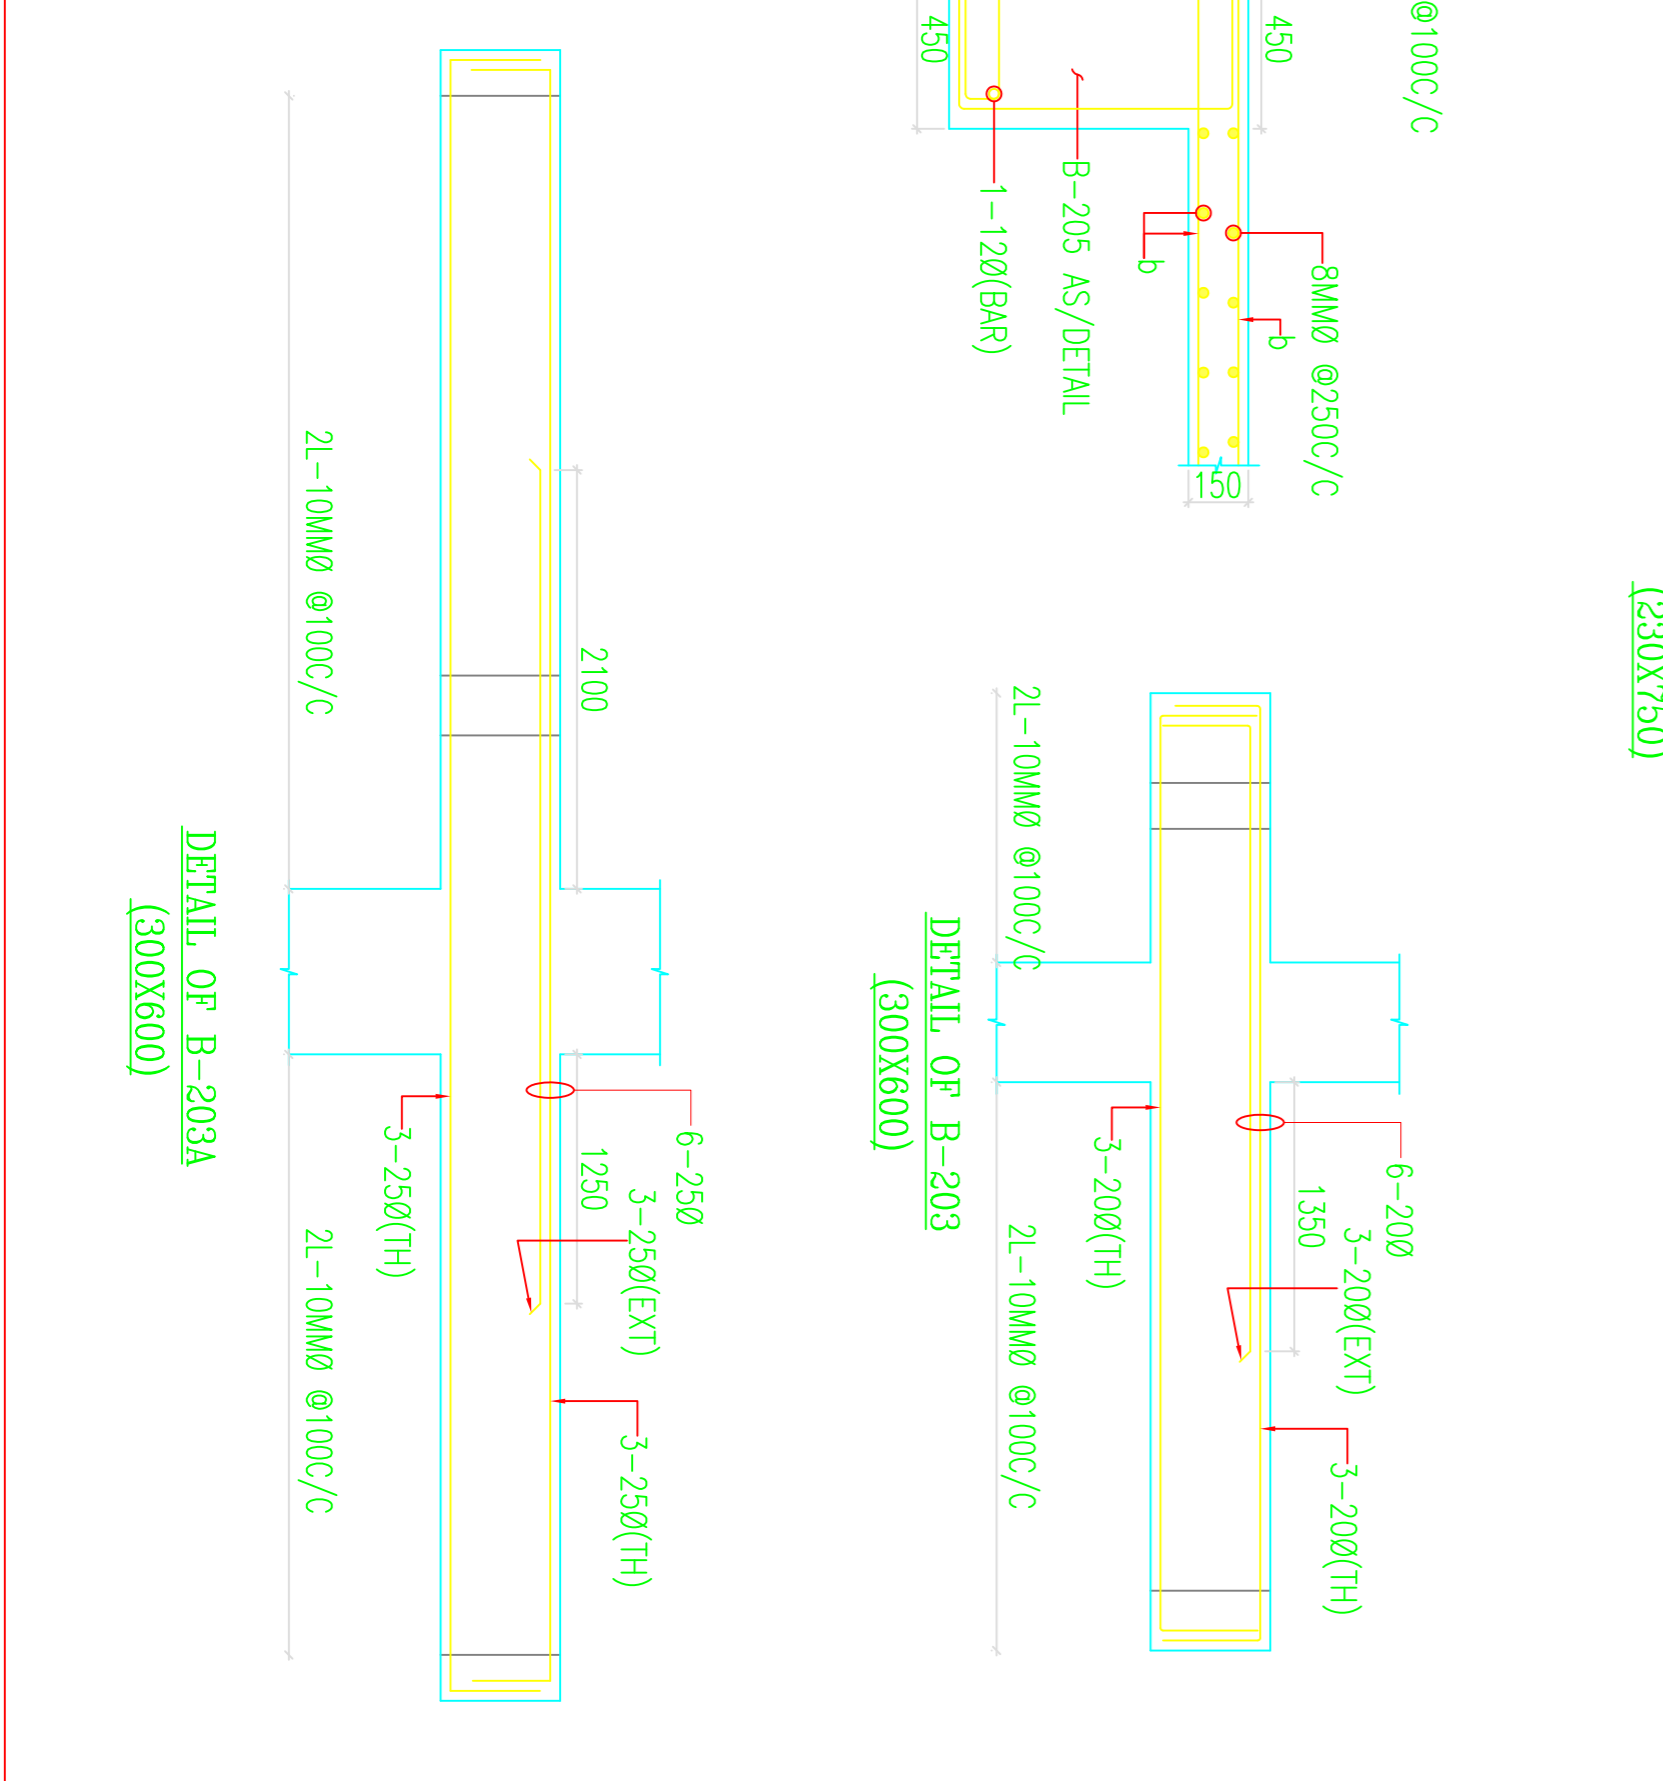
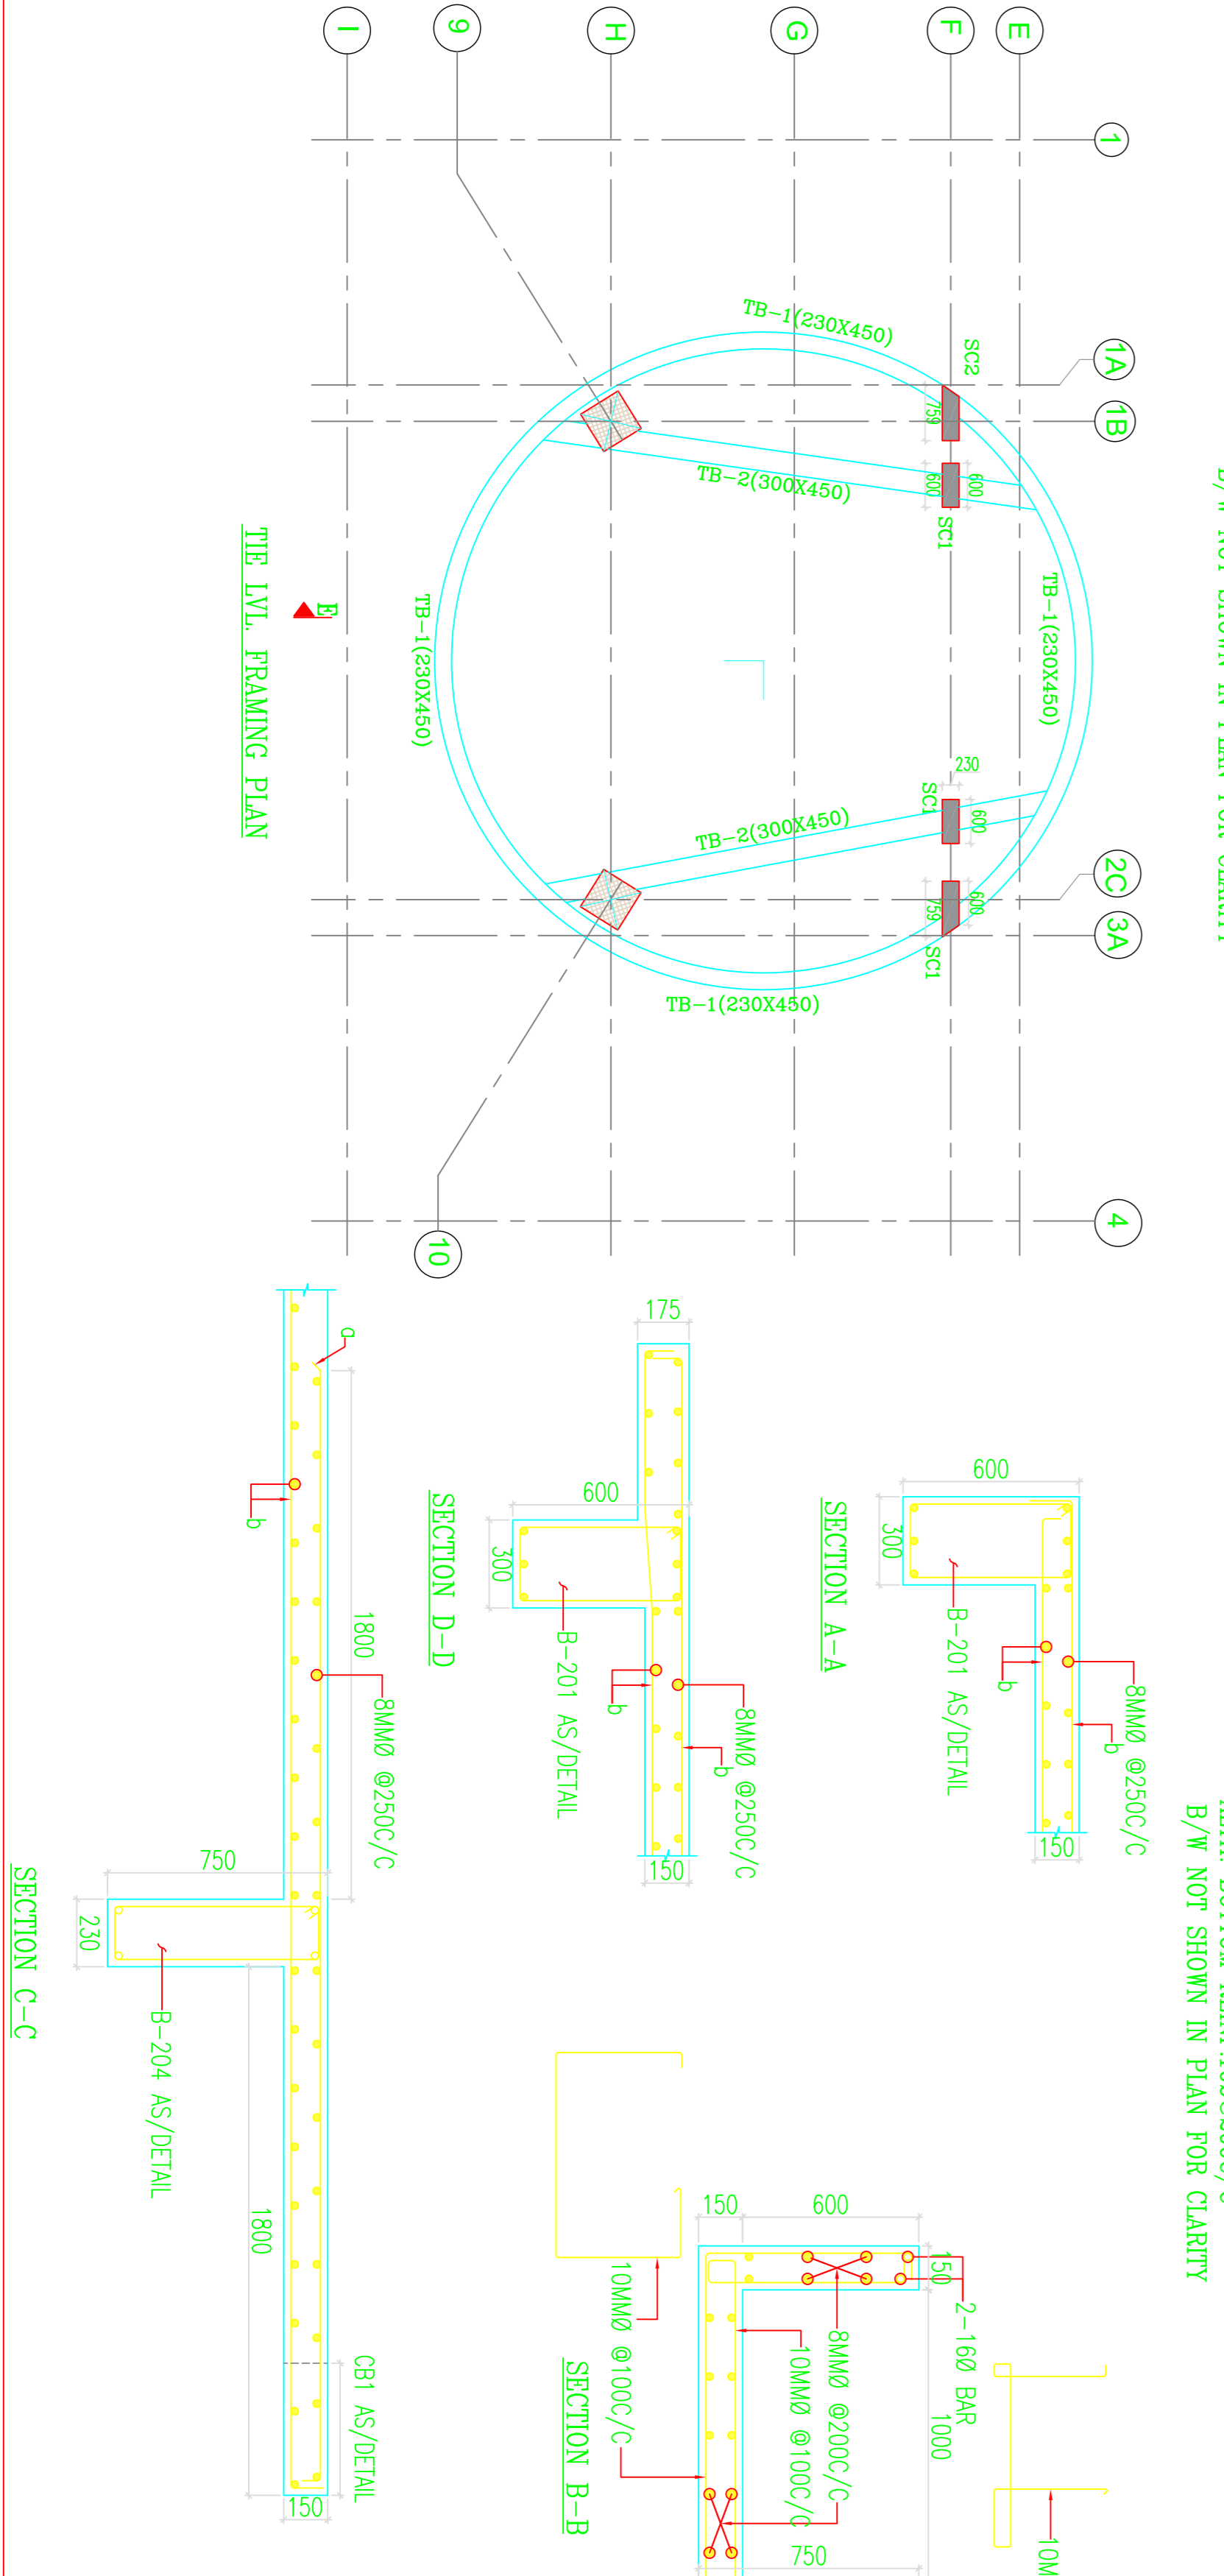
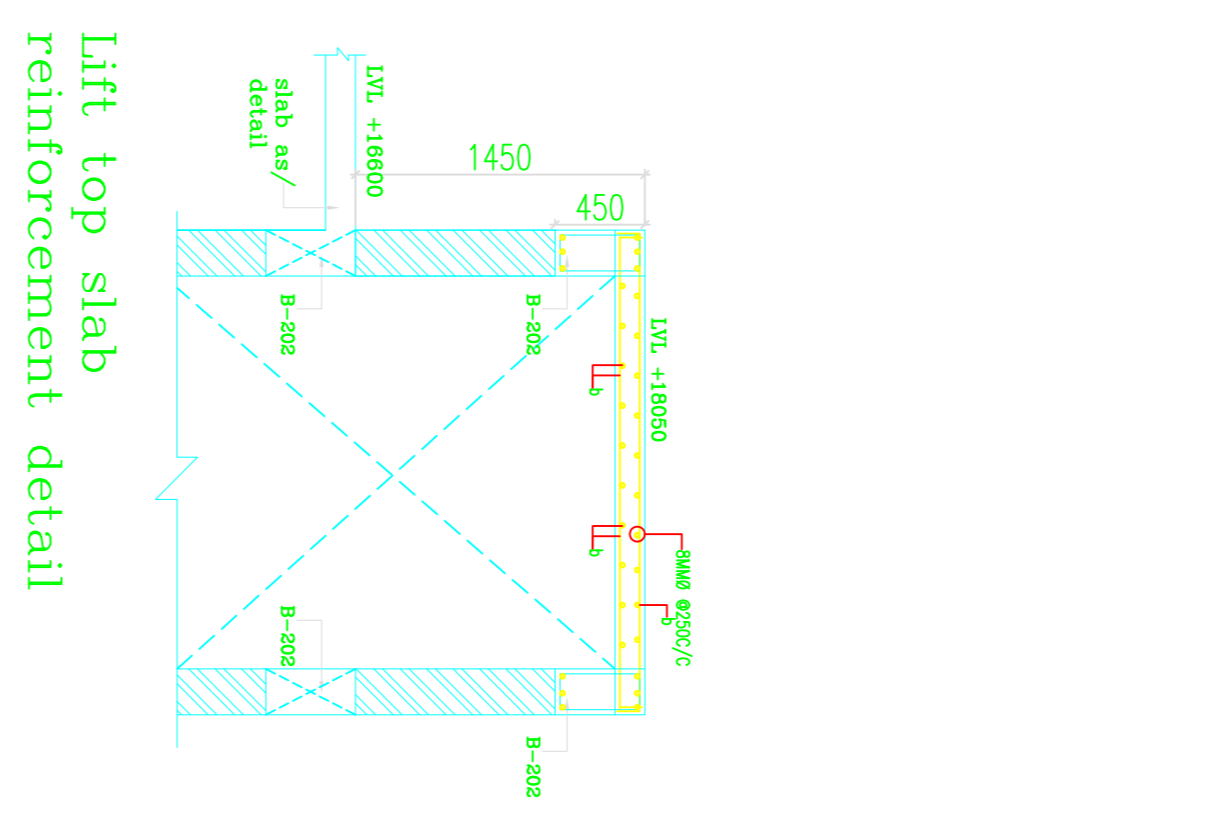
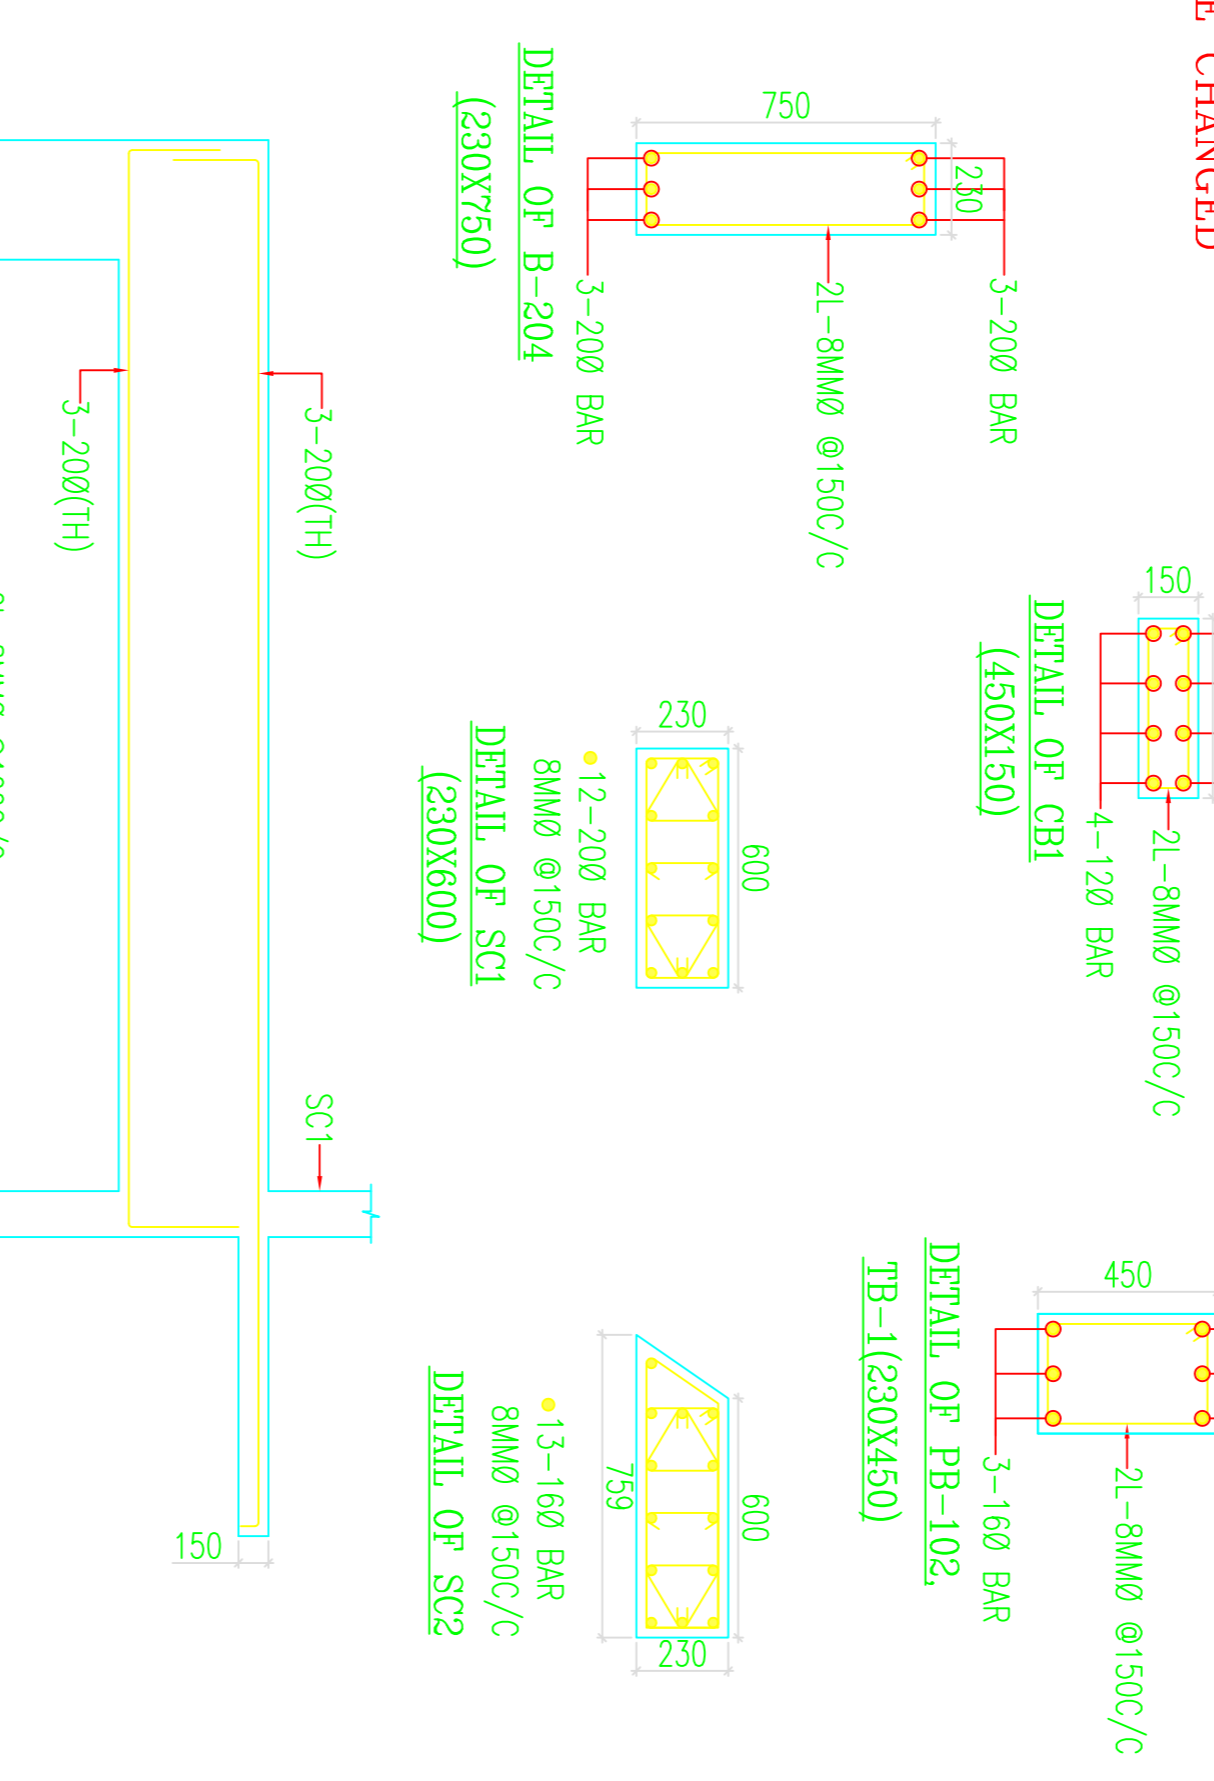


NOTES:-

- ALL DIMENSIONS ARE IN MILLIMETERS UNLESS NOTED OTHERWISE.
- ANY DISCREPANCY IN THE DRAWING SHALL BE BROUGHT TO THE NOTICE OF THE ENGINEER.
- THIS DRAWING SHALL BE READ IN CONJUNCTION WITH OTHER RELEVANT DRAWINGS.
- CON. MIX - M25.
- GRADE OF REINF. - Fe 500.

BEAM SIZE	
BS-1	300X600
BS-2	230X600
BS-3	230X450
BS-4	450X750
BS-5	230X750

SLAB REINF. MARKED	
a	12MMØ @ 100c/c
b	10MMØ @ 200c/c

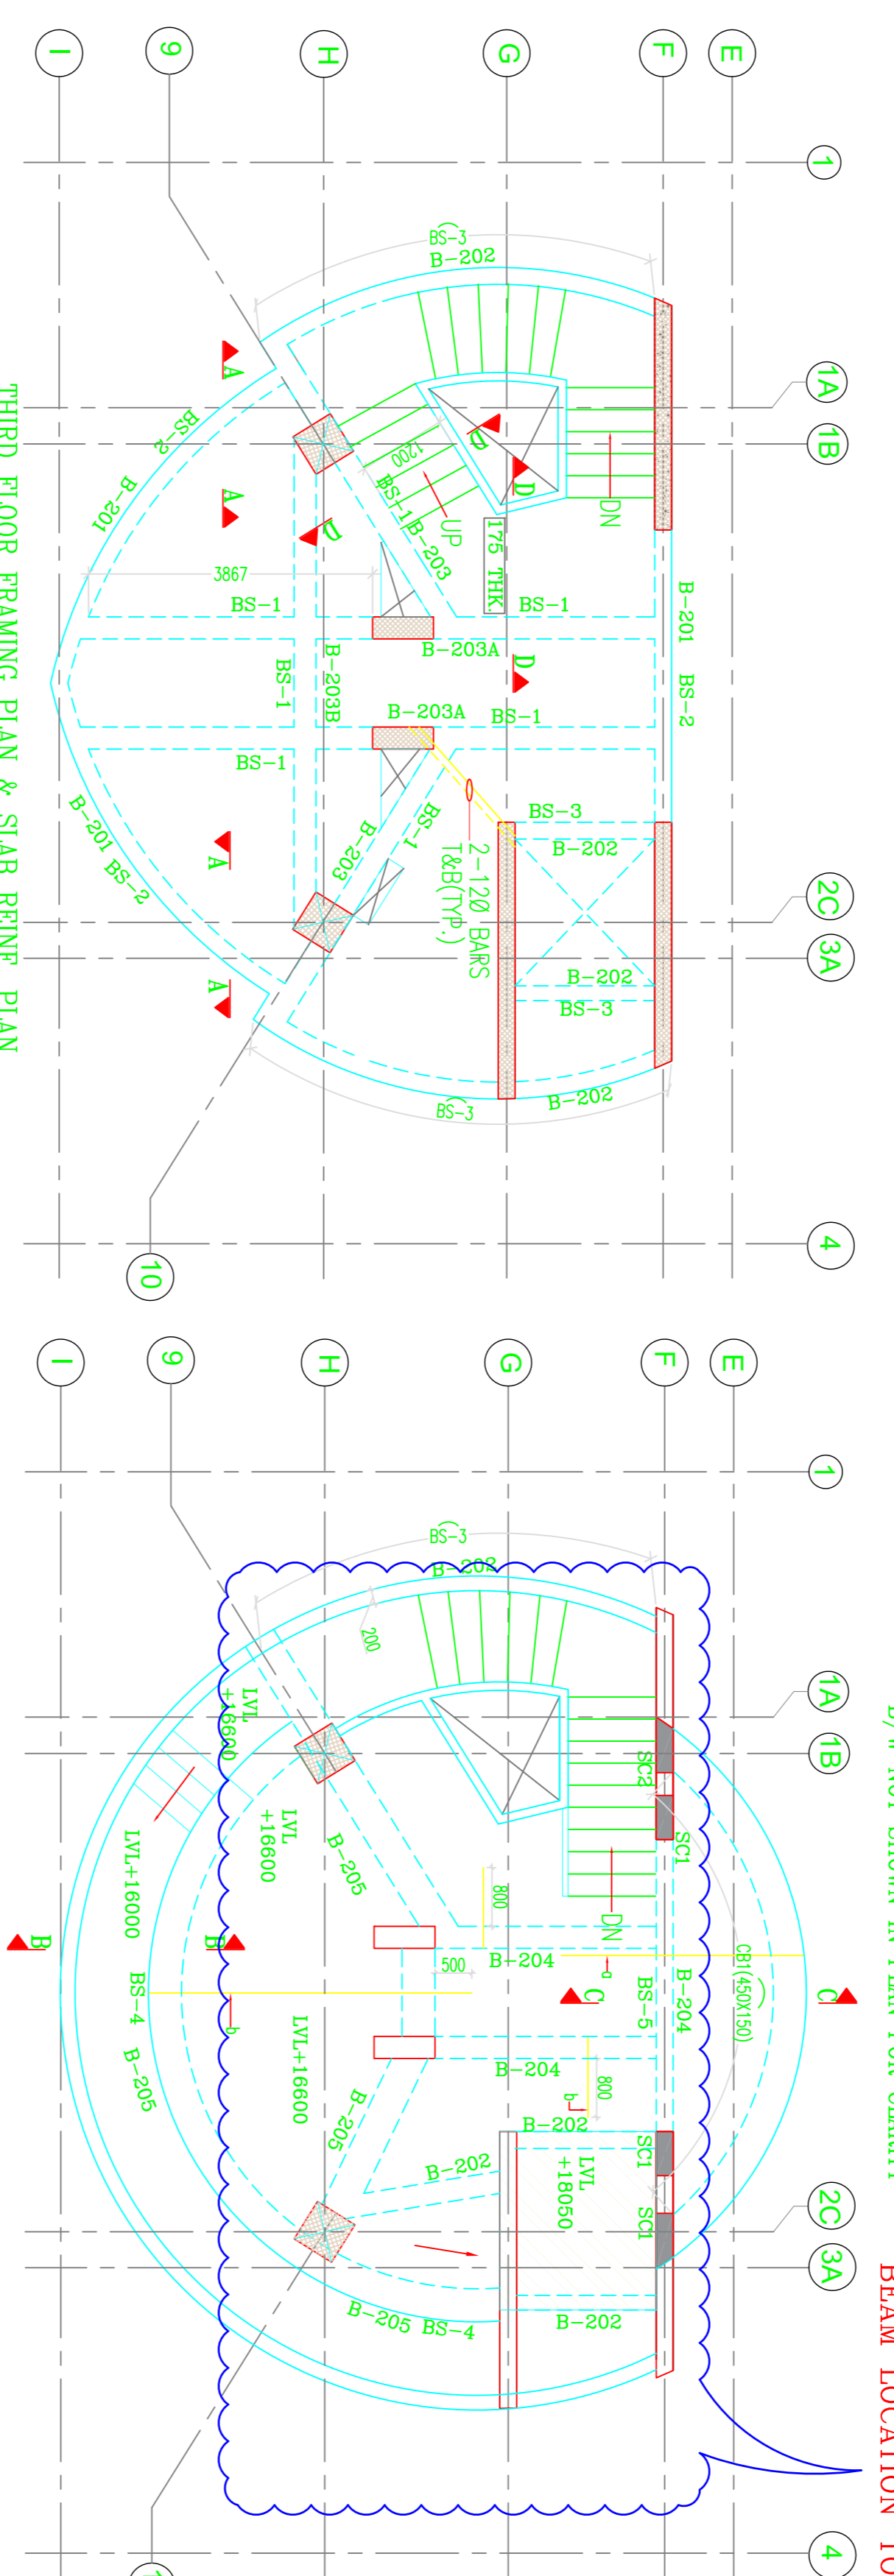

REV.	DATE	PREP.	CHK.	APP.	DESCRIPTION
R1	03-11-2018				Store/raise location change on fourth floor

PRODUCT PROPONENT
BHOOGAPURAM INTERNATIONAL AIRPORT CORPORATION LIMITED
(BHOAC) (SOV. OF A.P.)

CONSULTANT
IRITES
THE INFRASTRUCTURE DEVELOPER
AIRPORTS DIVISION
(ISO - 9001 CERTIFIED)

ARCHITECT
Renu Khanna & Associates
architect, engineers, interior & landscape planner
100, Park Road, Park Road, Hyderabad
India-501409
Ph. +91-172-2659379 Fax. +91-172-26594538
email: renu.khanna.arch@rka.com

JOB TITLE
DEVELOPMENT OF GREEN FIELD AIRPORT AT ORAVAKALLU
(KURNOOL), A.P., FOR DAY VRS
OPERATIONS OF ATR 72 AIRCRAFT



REVISION
DATE: 01-06-2018
CHECKED: NARESH (ATC)
DEPARTMENT: ENGINEERING
SCALE: 1 : 75
PROJECT CODE: NLE-S-202(R2)

DOCUMENT TITLE: **REINF. DETAIL (ATC)**










PREPARED: 01-06-2018
CHECKED: NARESH (ATC)
DEPARTMENT: ENGINEERING
SCALE: 1 : 75
PROJECT CODE: NLE-S-202(R2)

SHEET 1/1

TYPICAL STAIRCASE STRUCTURE TO BE FOLLOWED FROM BOTTOM TO TOP INSTEAD OF SEPERATE STAIRCASE AT LEVEL 13400

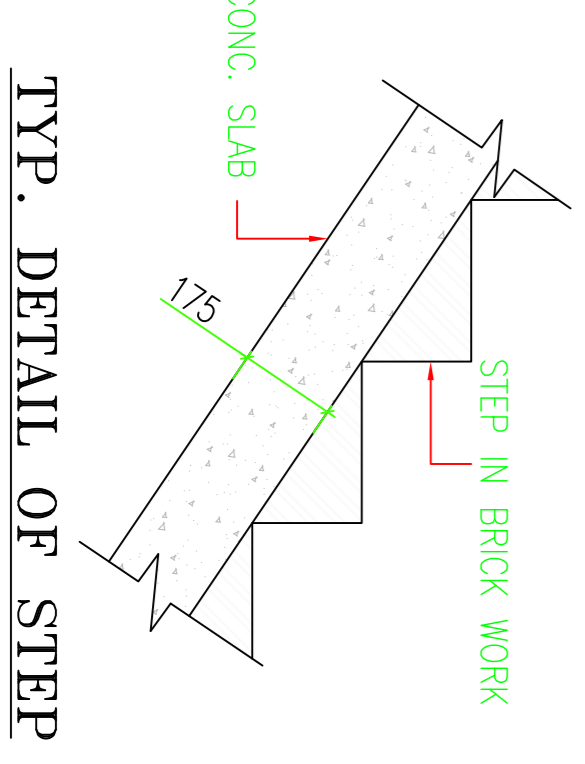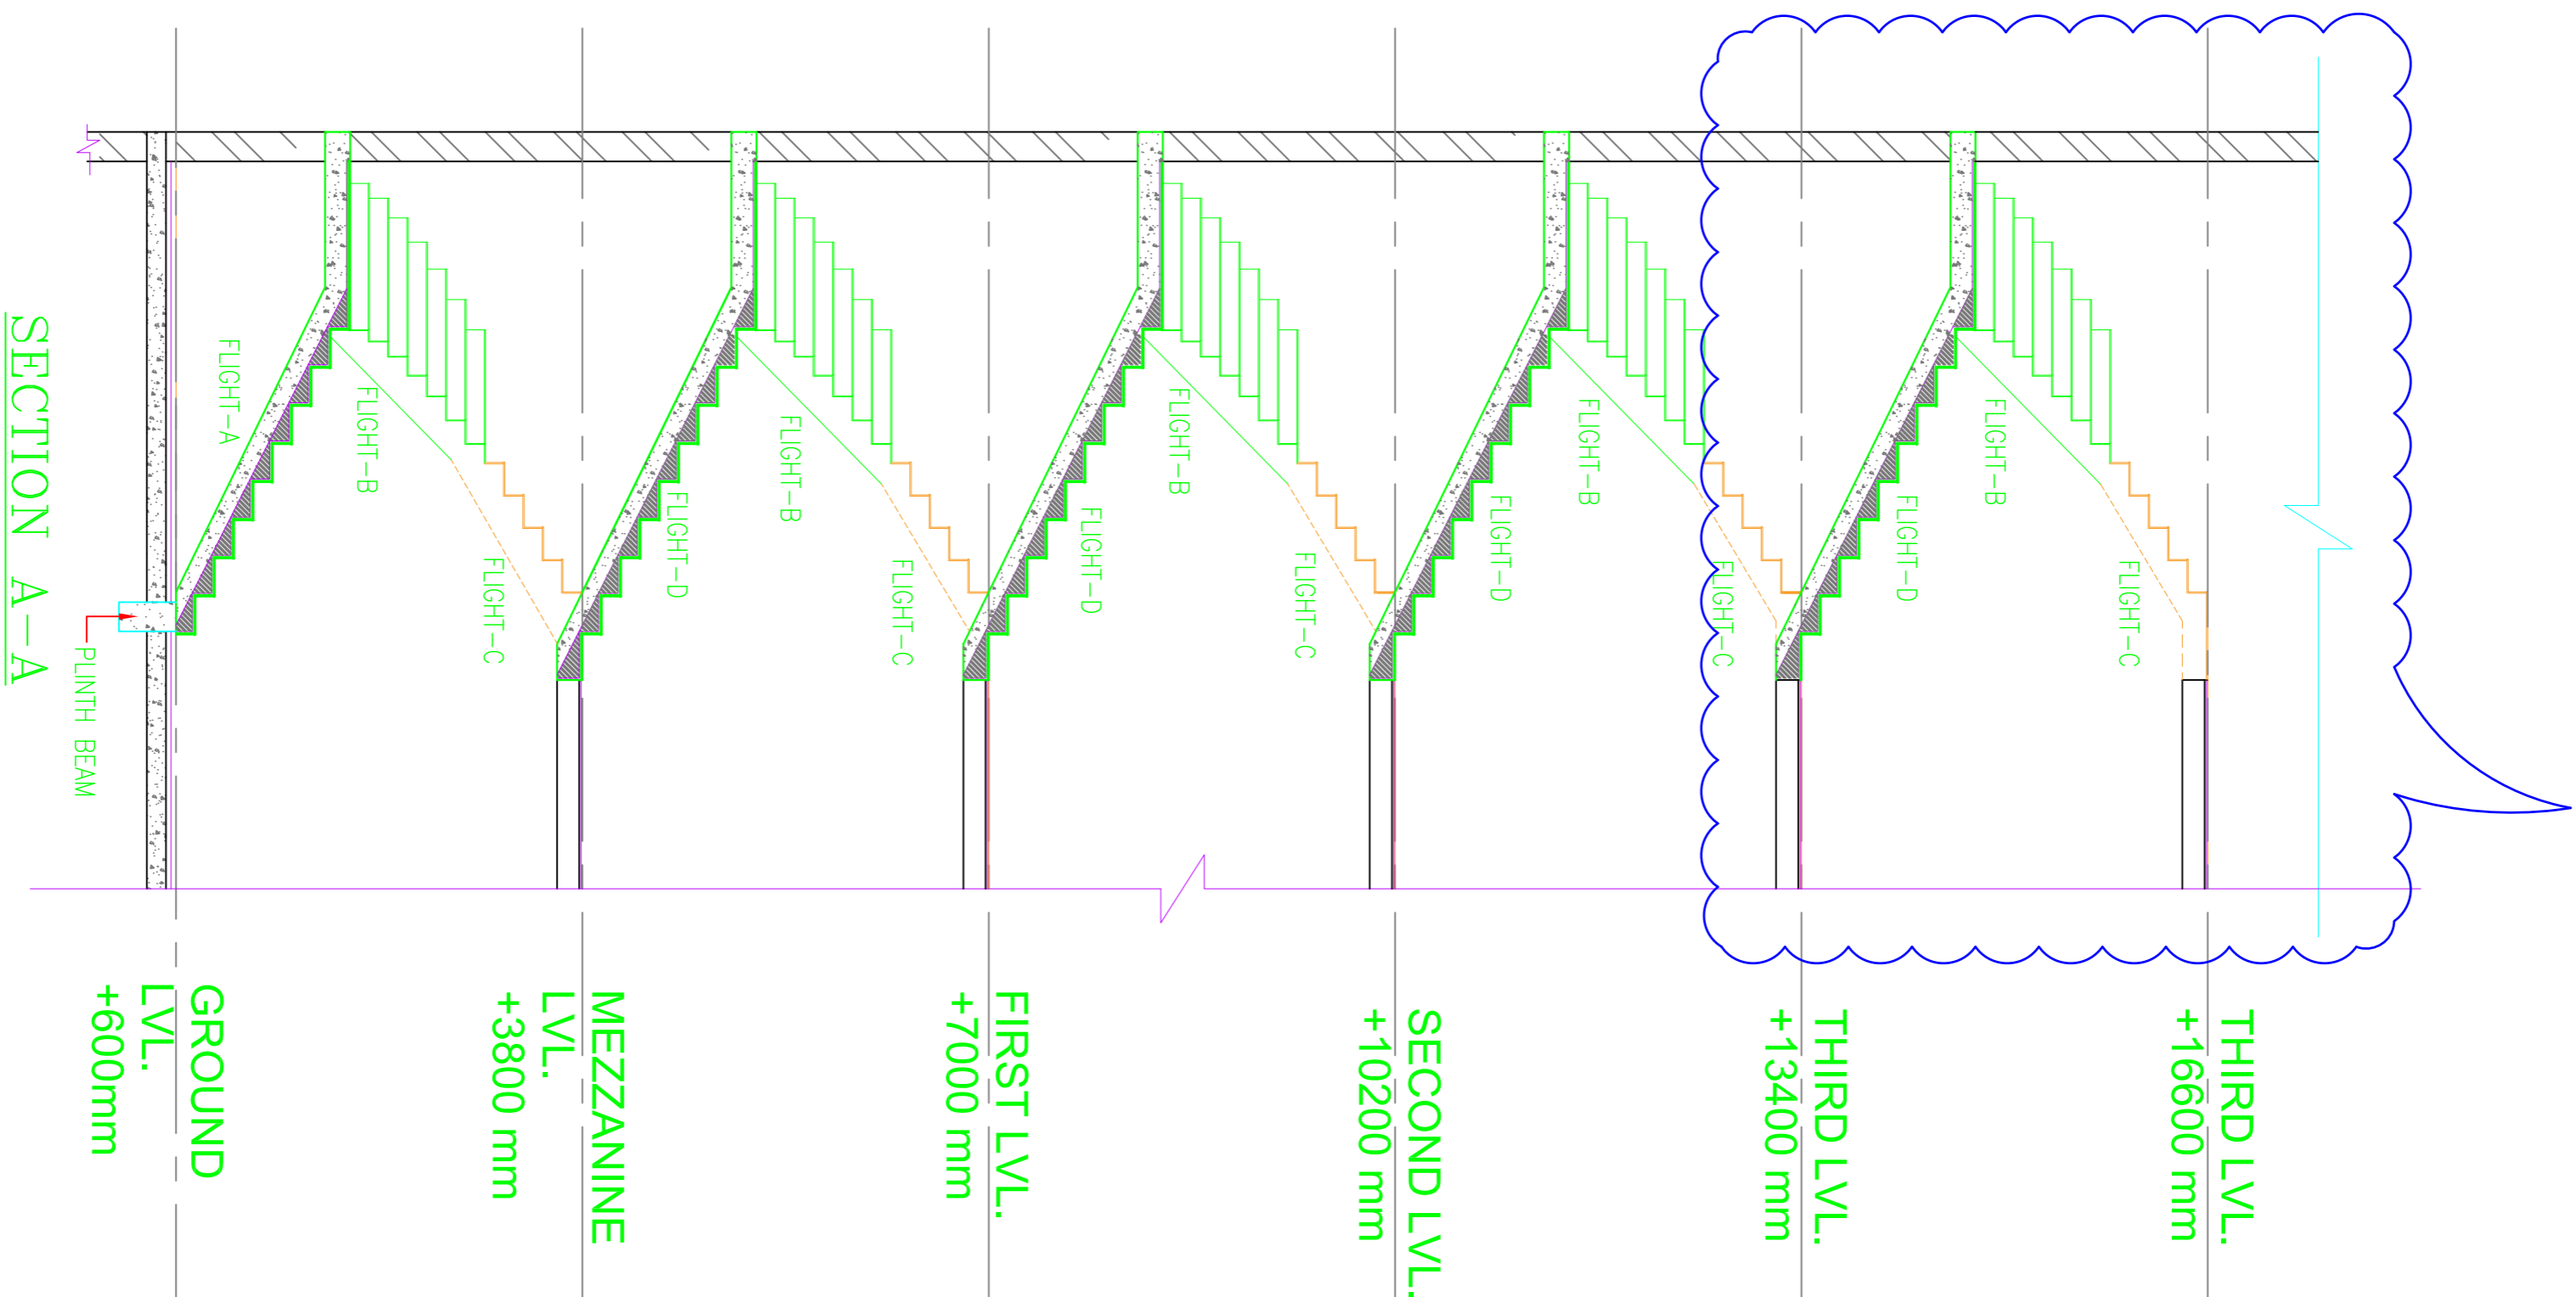

ALL WAST SLAB ARE 175THK.

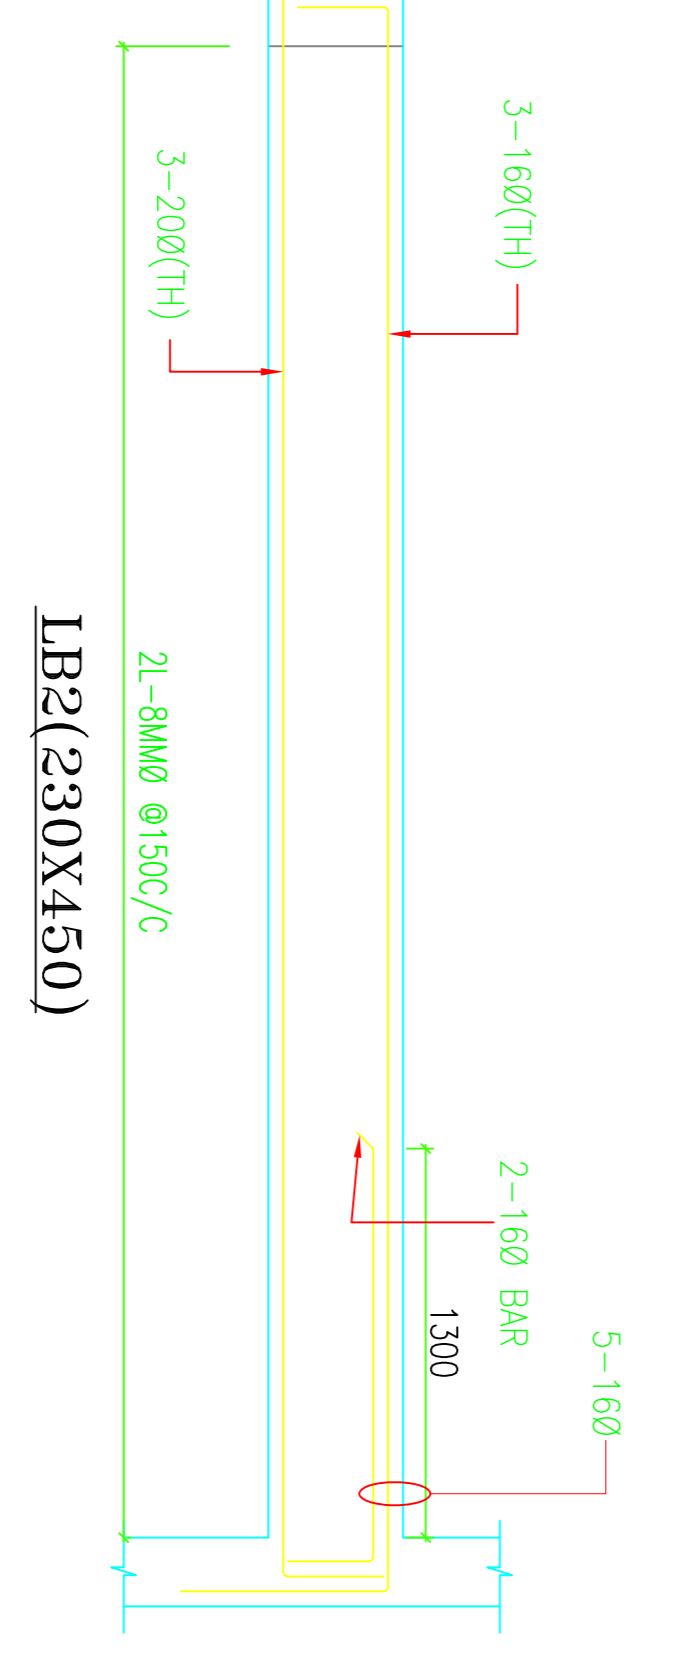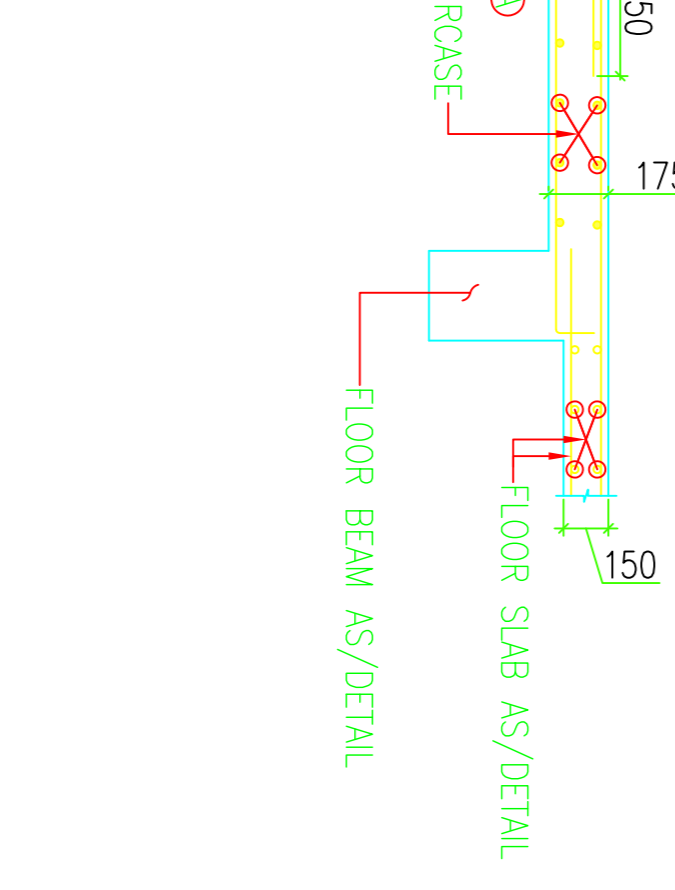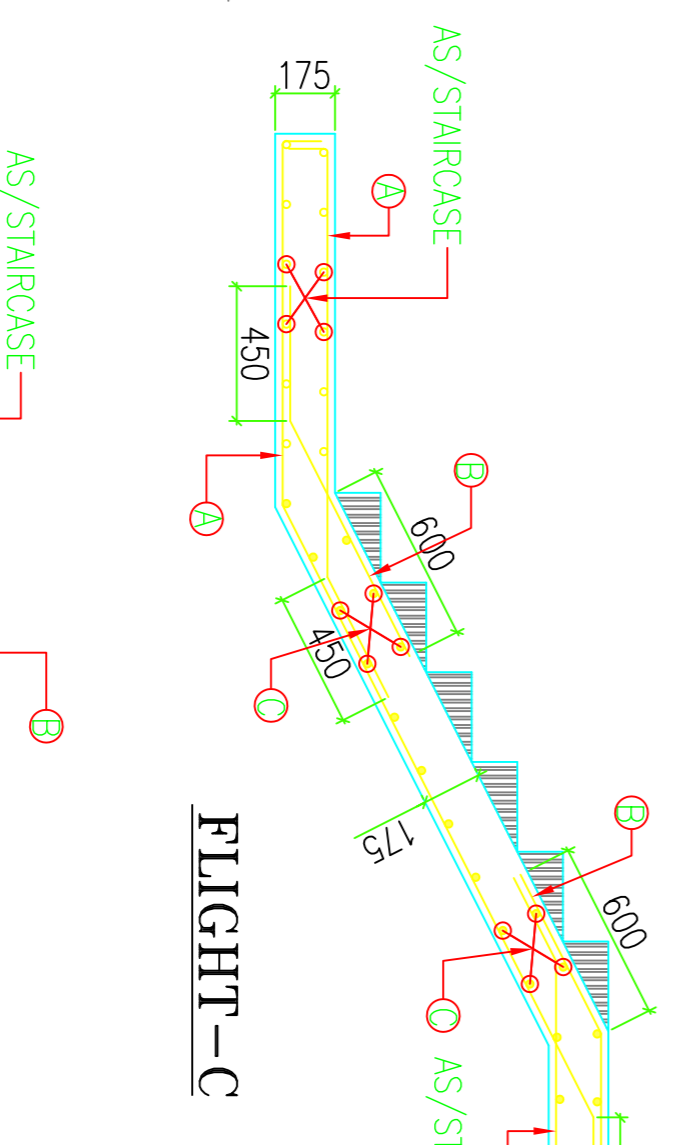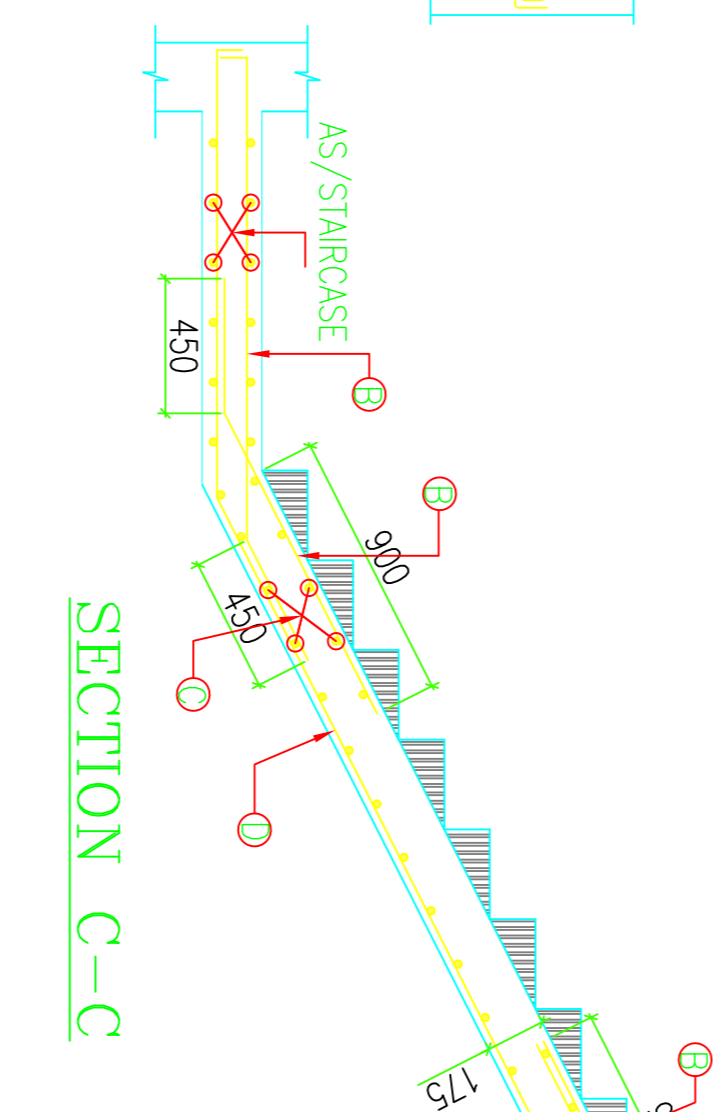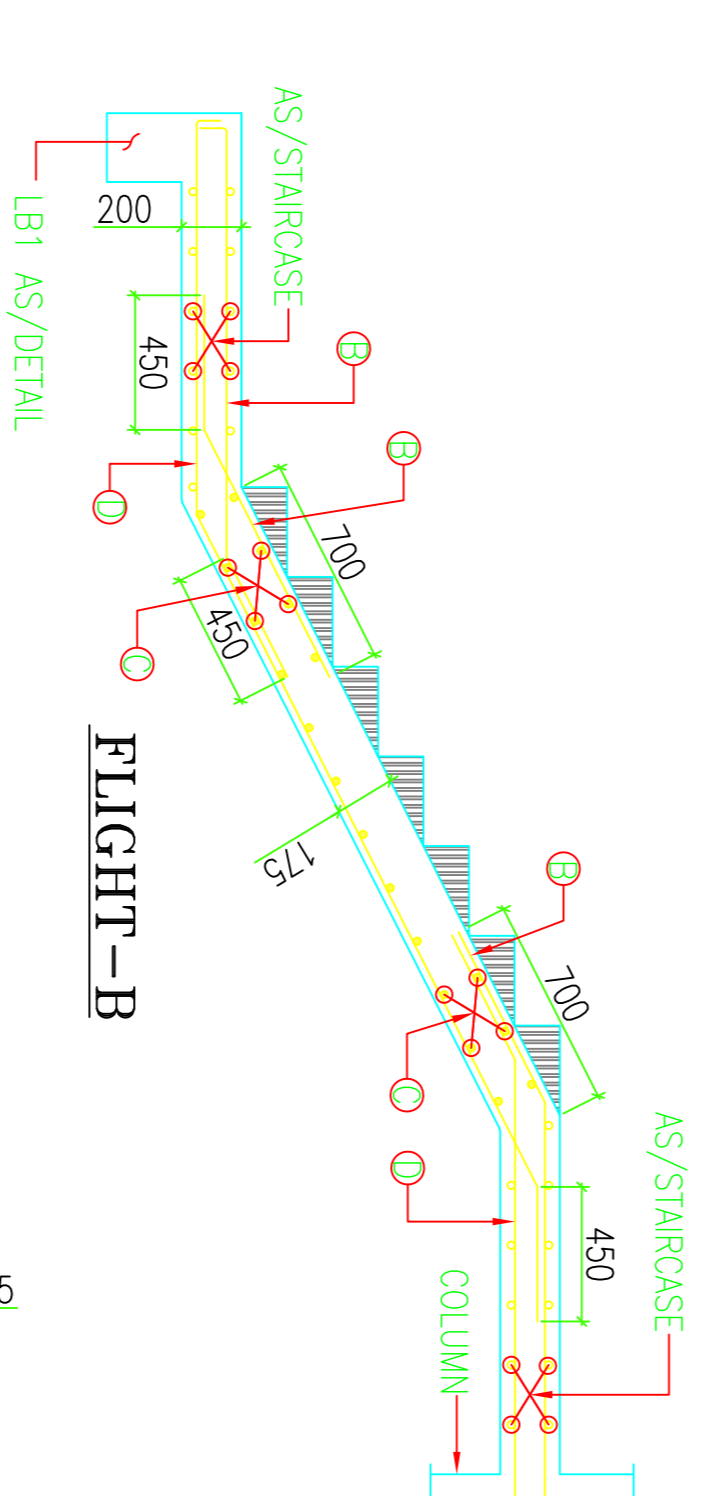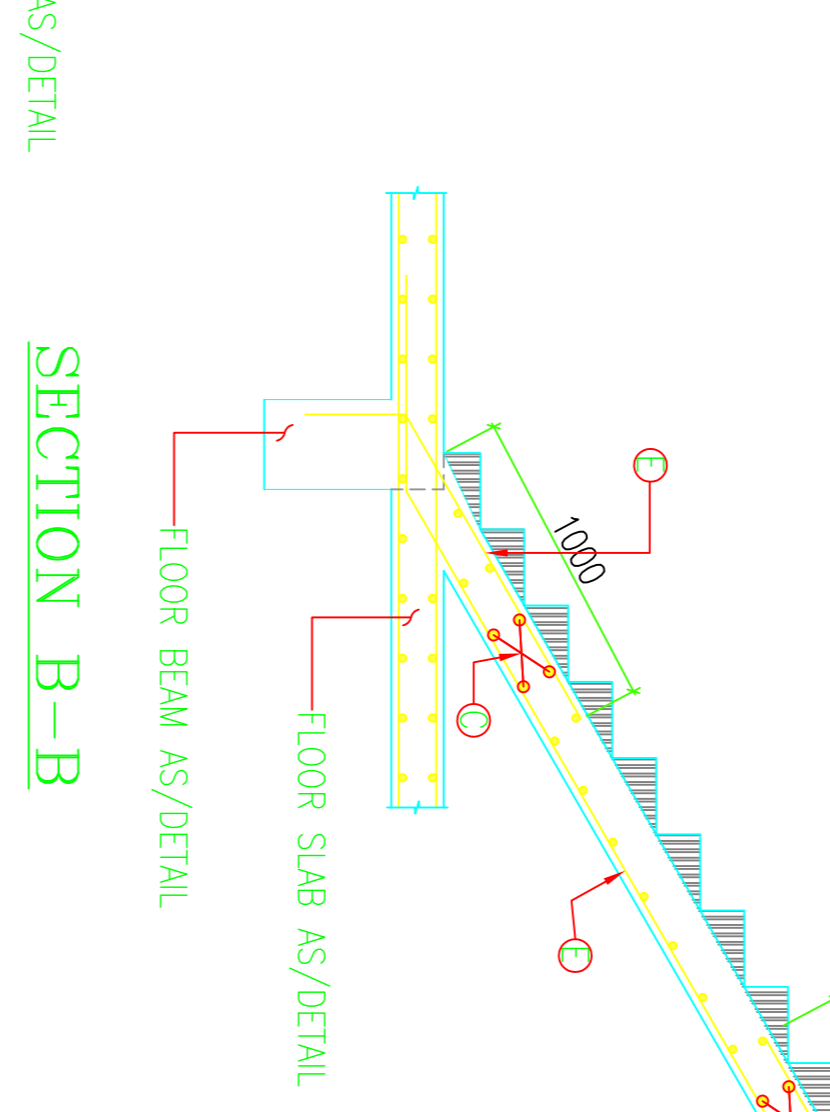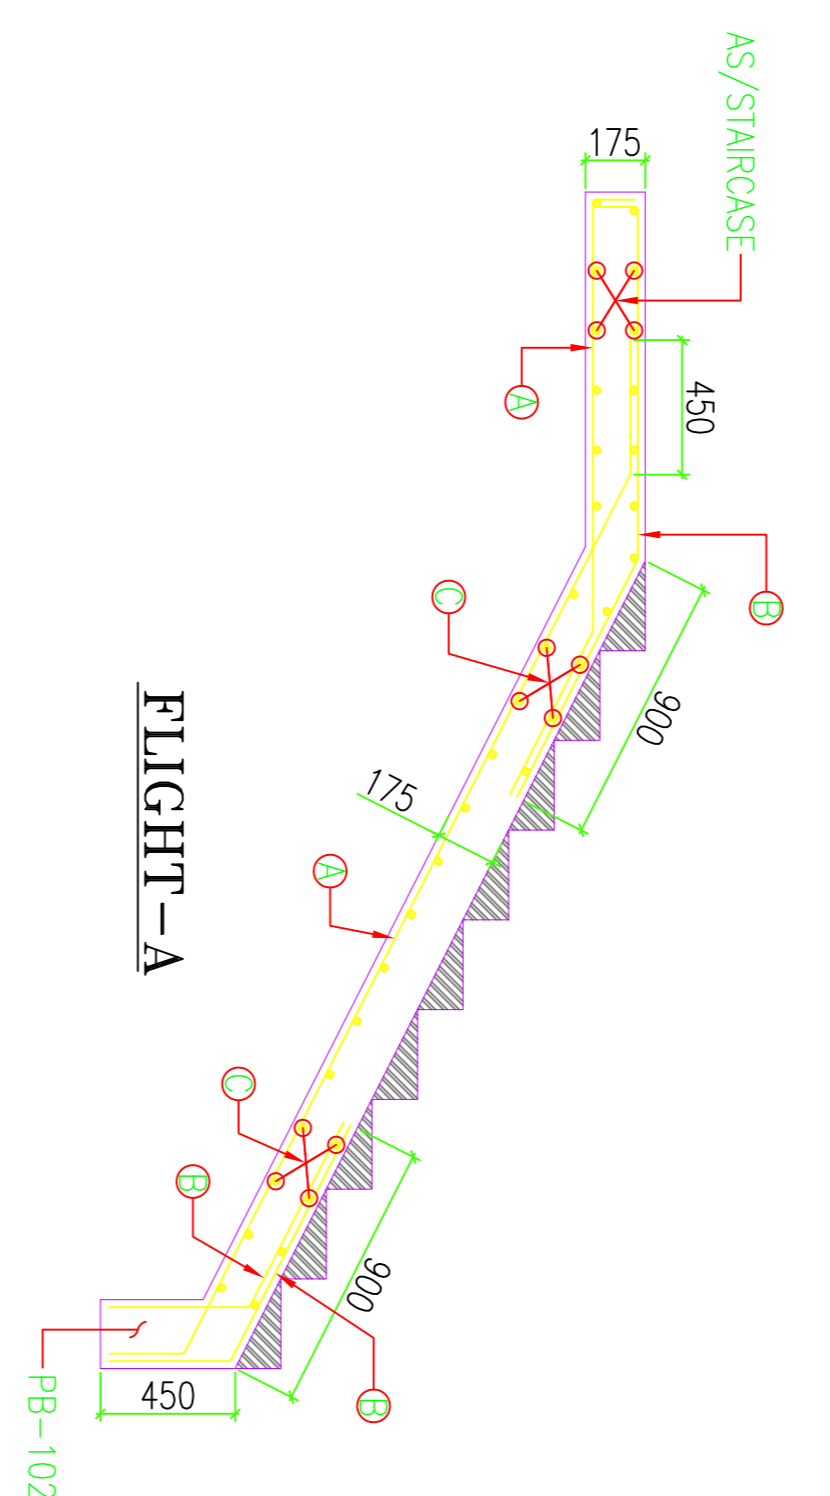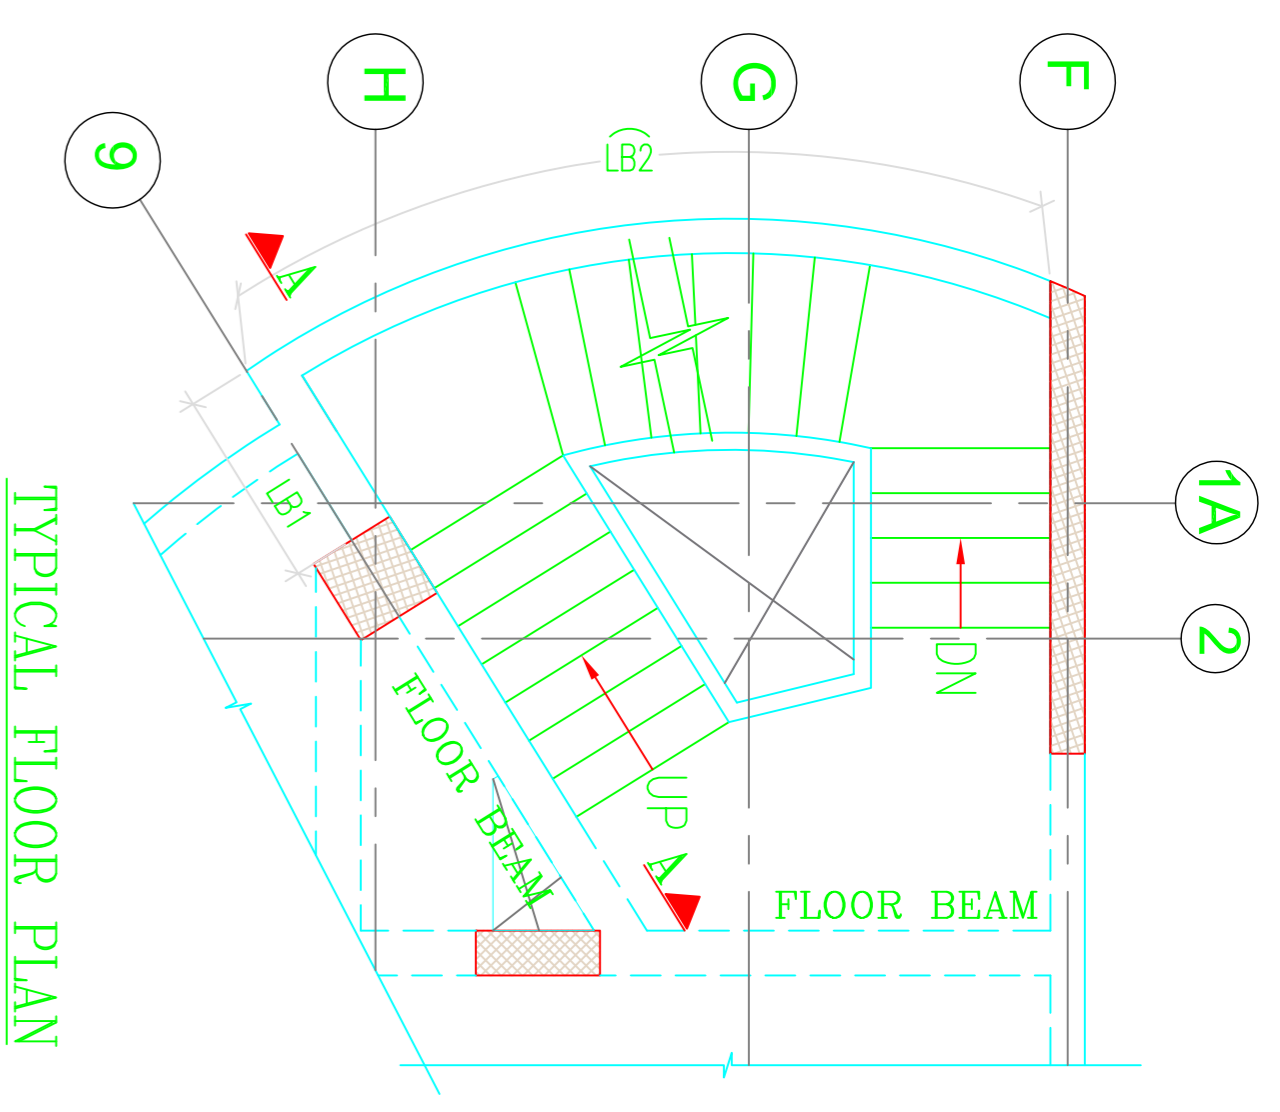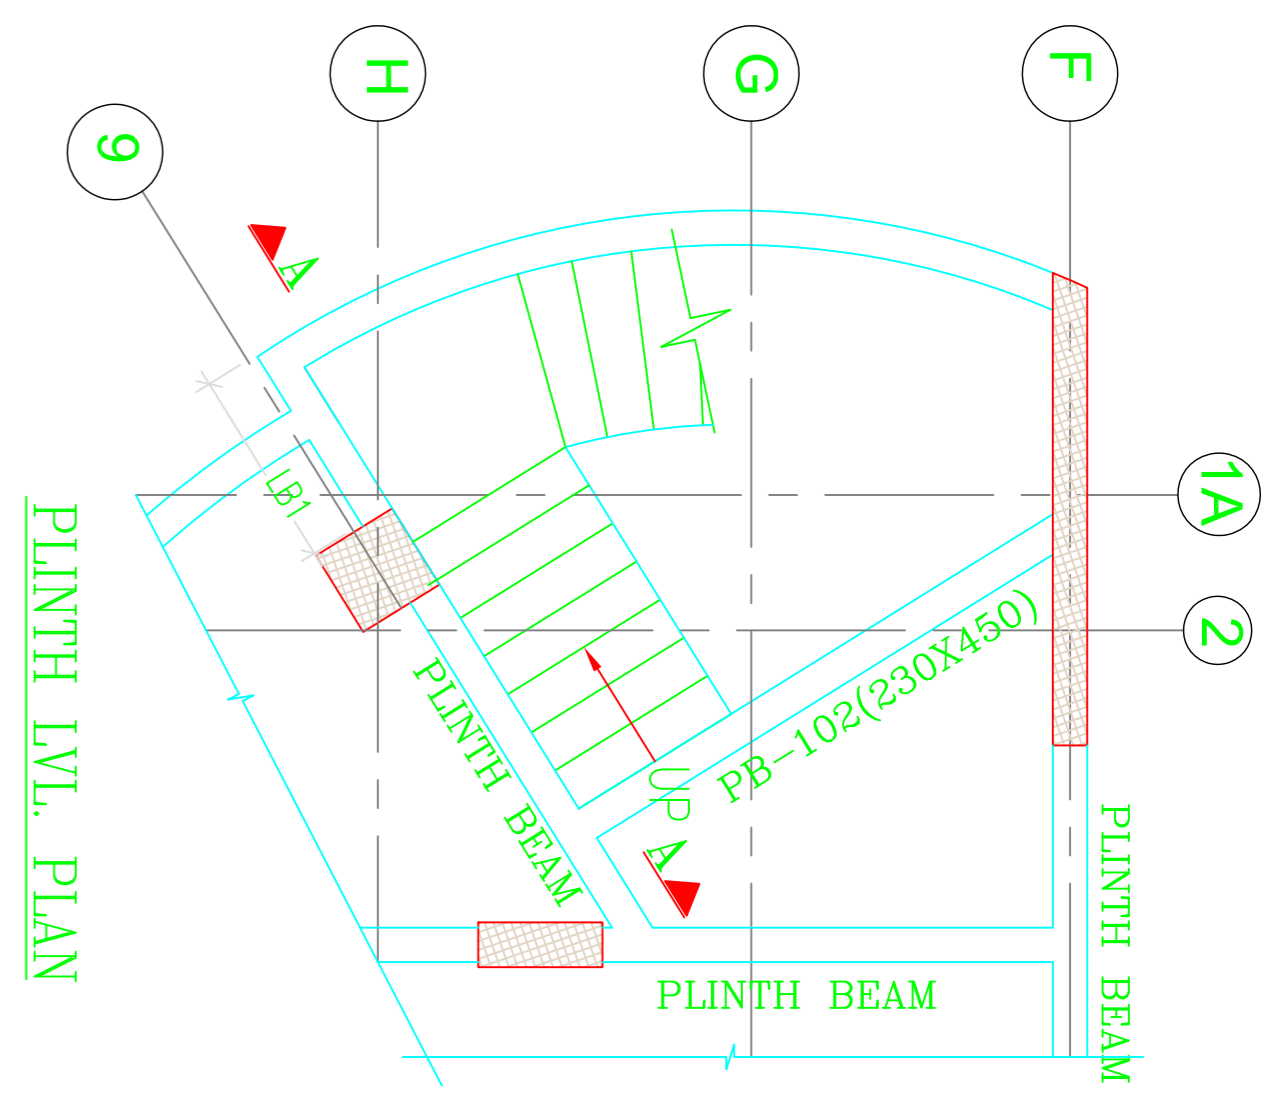

REINF. SCHEDULE

A	160@100 C/C
B	100@200 C/C
C	80@200 C/C
D	120@150 C/C
E	100@150 C/C

- NOTES:-
1. ALL DIMENSIONS ARE IN MILLIMETERS UNLESS NOTED OTHERWISE.
 2. ANY DISCREPANCY IN THE DRAWING SHALL BE BROUGHT TO THE NOTICE OF THE ENGINEER.
 3. THIS DRAWING SHALL BE READ IN CONJUNCTION WITH OTHER RELEVANT DRAWINGS.
 4. CON. MIX - M25.
 5. GRADE OF REINF. - Fe 500.

REV.	DATE	PREP.	CHK.	APP.	DESCRIPTION
R1	03-11-2018				Staircase location change on (South) floor

PRODUCT PROPONENT
BHOGAURAM INTERNATIONAL AIRPORT CORPORATION LIMITED
(BIACL) (GOV. OF A.P.)

CONSULTANT
IPRITES
THE INFRASTRUCTURE PEOPLE
AIRPORTS DIVISION
(ISO - 9001 CERTIFIED)

ARCHITECT
Renu Khanna & Associates
architect, engineers, interior & landscape planner
INDIA-134109
Ph. - +91-172-2456379
email: renukhannaarchitect@yahoo.com

JOB TITLE
DEVELOPMENT OF GREEN FIELD AIRPORT AT ORYKALLU (KURNOOL), A.P., FOR DAY VRS OPERATIONS OF ATR 72 AIRCRAFT

DOCUMENT TITLE
FOUNDATION PLAN & DETAIL (LNC)

PREPARED : DATE : 01-06-2018
CHECKED : DATE : 01-06-2018
DRAWN : DATE : 01-06-2018

DEPARTMENT : ENGINEERING
SCALE : 1 : 60
FORMAT : A1
REVISION : R2
SHEET : 1/1

PROJECT CODE : NLE-S-203