

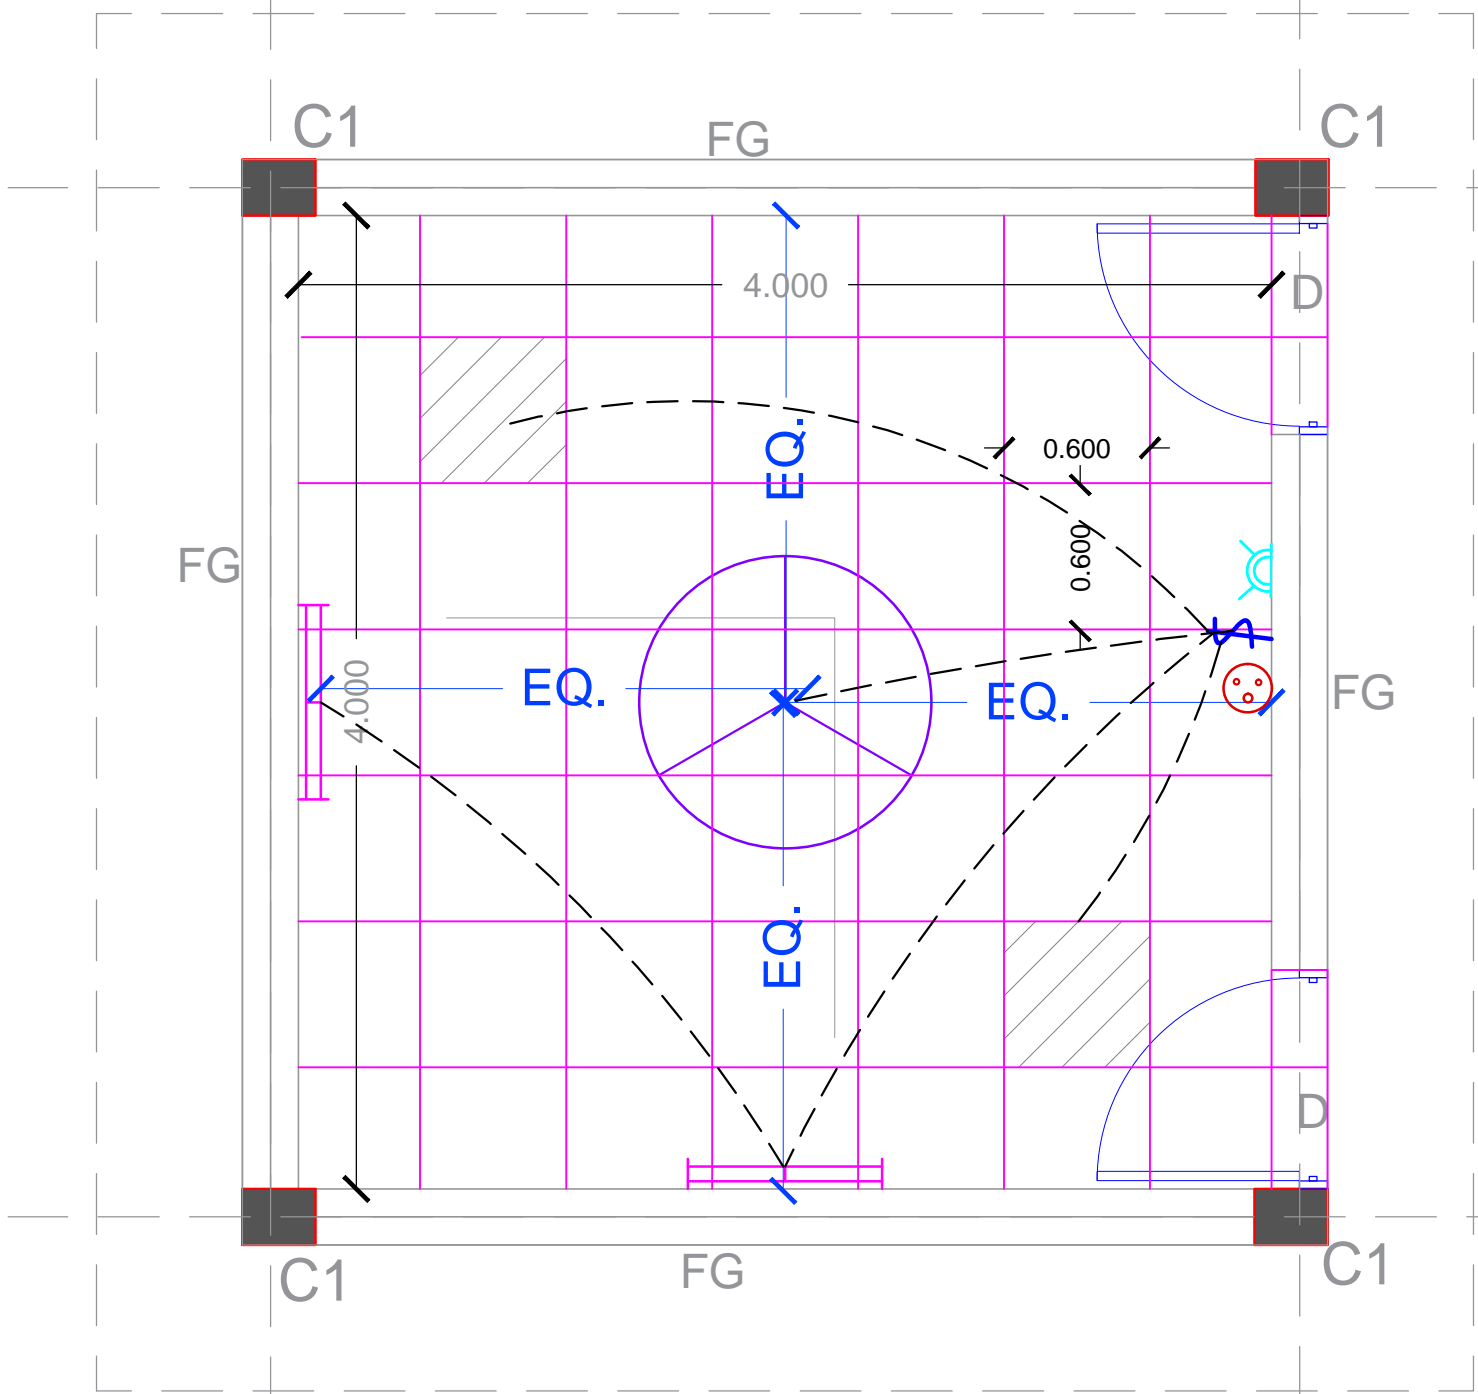
PROJECT PROPONENT
 BHOGAPURAM INTERNATIONAL AIRPORT CORPORATION LIMITED
 (BIACL) GOVT. OF A.P.






JOB TITLE
 DEVELOPMENT OF GREEN FIELD AIRPORT AT ORVAKALLU
 (KURNOOL), A.P., FOR DAY VFR OPERATIONS OF ATR 72 AIRCRAFT

CONSULTANT

 THE INFRASTRUCTURE PEOPLE
 AIRPORTS DIVISION
 (ISO - 9001 CERTIFIED)

- NOTES:-
1. ALL DIMENSIONS ARE IN MILLIMETERS UNLESS NOTED OTHERWISE.
 2. WRITTEN DIMENSIONS ARE TO BE FOLLOWED. DRAWINGS ARE NOT TO BE SCALED.
 3. ANY DISCREPANCY IN THE DRAWING SHALL BE BROUGHT TO THE NOTICE OF THE ENGINEER.
 4. THIS DRAWING SHALL BE READ IN CONJUNCTION WITH OTHER RELEVANT DRAWINGS.



LEGEND SHEET	
SYMBOL	DESCRIPTION
	CEILING FAN
	SWITCH BOARD
	1No. 6A SWITCH + 1No. 6A SOCKET
	1No. 16A SWITCH + 1No. 16A SOCKET
	LIGHT(600x600)


PLAN

Renu Khanna & Associates
 architect, engineers, interiors & landscape planner
 #138, sec-10, Panchkula, Haryana India-134109
 Ph. - +91-172-2563379 Fax.- +91-172-2584538
 email: renukhanna.architect@yahoo.com
<http://www.architectsrenukhanna.com/>

- COMPLETION STAGE CONSTRUCTION STAGE
 TENDER STAGE CONCEPTUAL STAGE

SUFFIX	DATE	INITIALS	DETAILS

REVISIONS ELECTRICAL REVISED
 DRAWING TITLE
ELECTRICAL PLAN

Job. No.		Drg. No.	WD/FR/DT-01	
Scale		Date	19-10-2018	
NTS		Revision Suffix		
DRAWN		DEALT		CHECKED BY P.CORD.

COPYRIGHT
 THIS DRAWING IS THE PROPERTY OF RITES LTD. IT SHALL NOT BE REPRODUCED, COPIED, USED IN ANY MANNER OR HANDED OVER TO ANY OTHER PERSON OR PARTY, WITHOUT THE PRIOR PERMISSION OF RITES LTD.